



NOTES:


1. ALL DIMENSIONS ARE IN mm. NO DIMENSIONS SHALL BE SCALED FROM THE DRAWINGS.
2. THIS DRAWING IS PRODUCED FOR PLANNING PURPOSES ONLY. ALL DIMENSIONS AND REFERENCES GIVEN ARE FOR A GENERAL INSTALLATION AND SHOULD NOT BE USED AS PART OF DETAILED DESIGN. THIS DRAWING IS NOT FOR CONSTRUCTION.
3. CIVIL CALCULATIONS ARE TO BE CARRIED OUT AT THE DETAILED DESIGN STAGE AND TAKE INTO ACCOUNT SPECIFIC, EXISTING SITE GROUND CONDITIONS.
4. FOUNDATION DIMENSIONS ARE TO BE CONFIRMED AT DETAILED DESIGN.

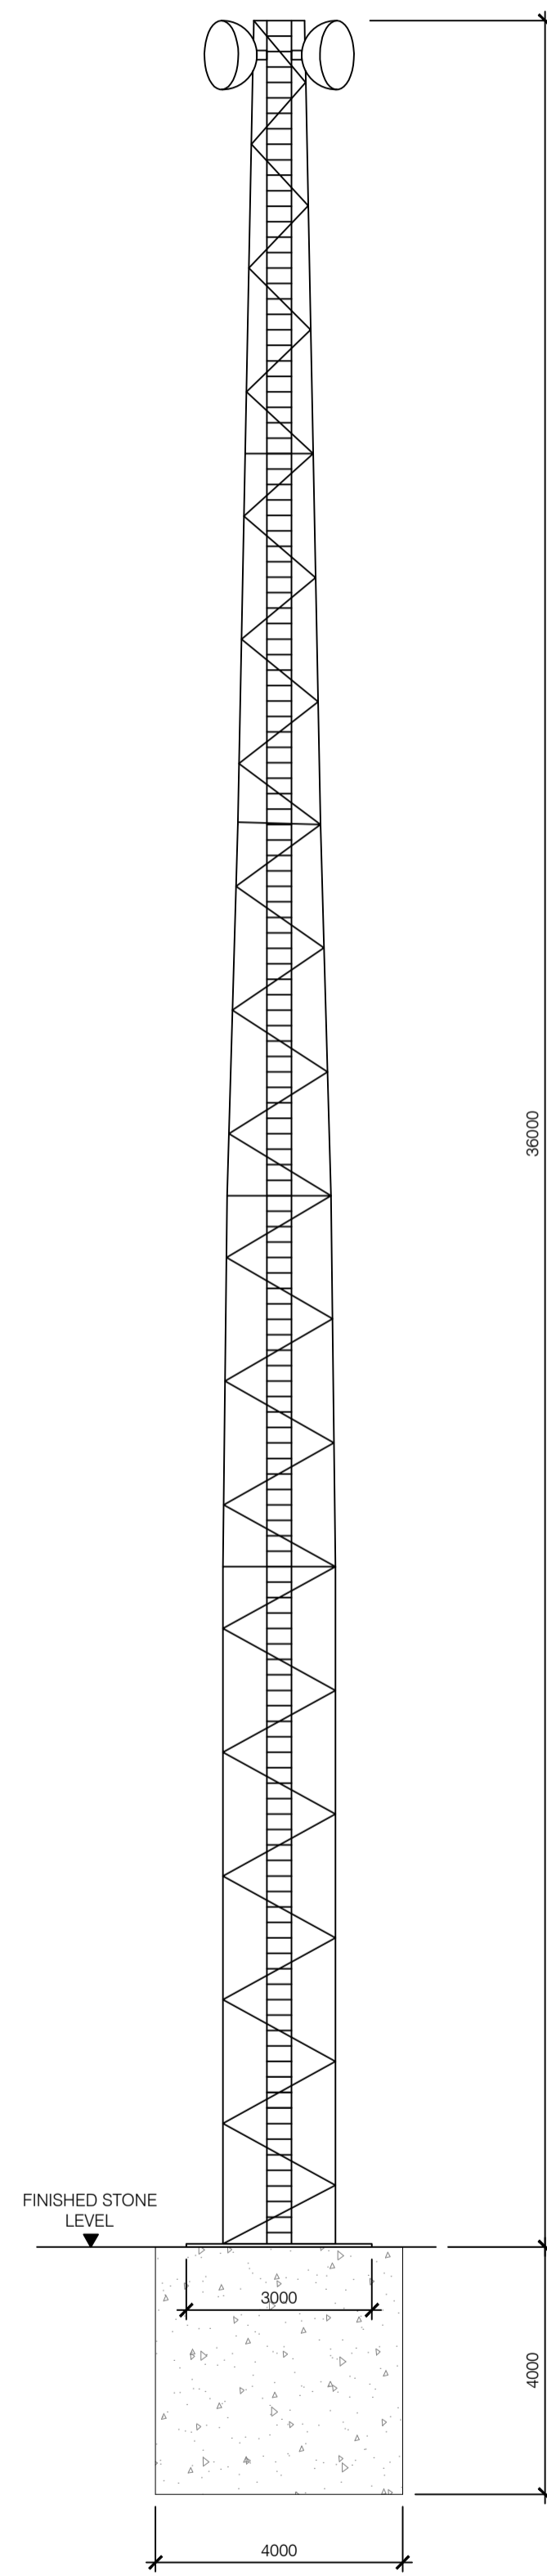


FRONT ELEVATION
SCALE 1:100

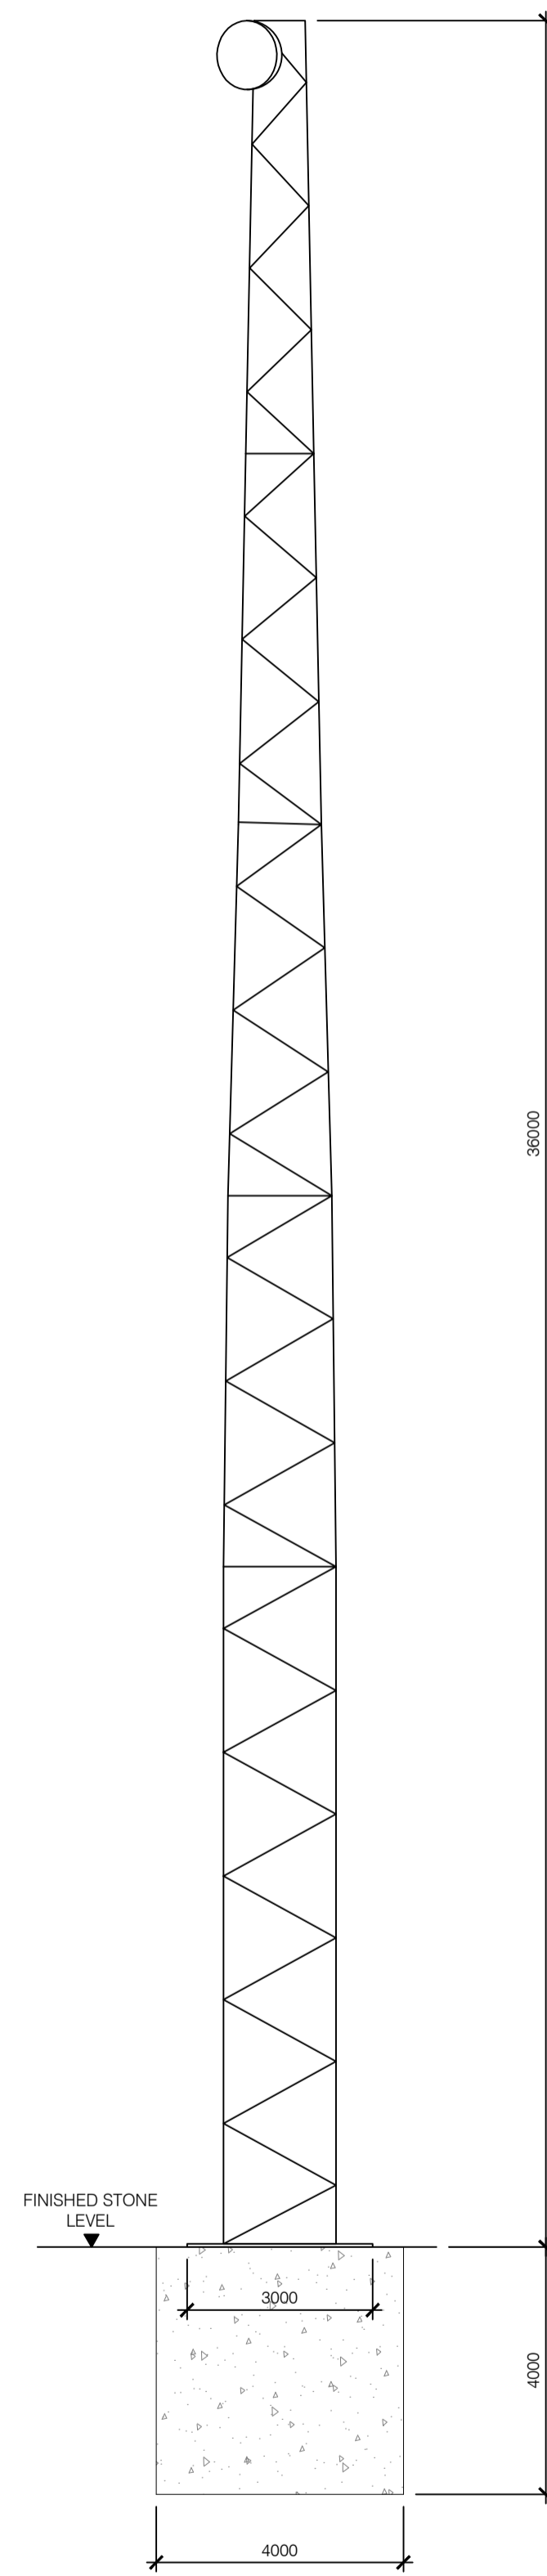

SIDE ELEVATION
SCALE 1:100

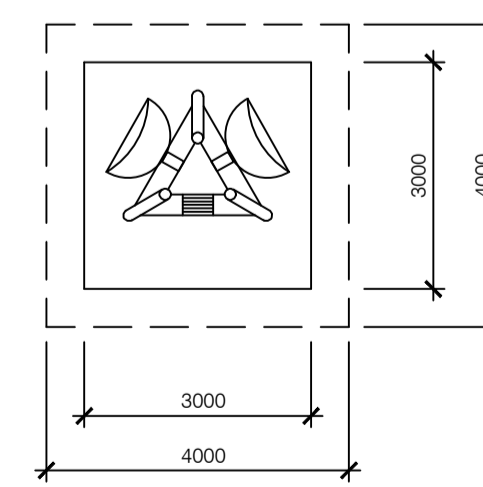

PLAN
SCALE 1:100

2	PROJECT TITLE REVISED								
1	21.08.23	PROJECT NAME REVISED	SB	SB	SD	JMcL			
0	29.04.22	INITIAL VERSION	SB	RH	AH	SK			
REV	DATE	REVISION DESCRIPTION	DRN	PROD	VER	APP			
<small>COPYRIGHT © ESB ALL RIGHTS RESERVED. NO PART OF THIS WORK MAY BE MODIFIED, REPRODUCED OR COPIED IN ANY FORM OR BY ANY MEANS - GRAPHIC, ELECTRONIC OR MECHANICAL, INCLUDING PHOTOCOPIING, RECORDING, TAPING OR USED FOR ANY PURPOSE OTHER THAN ITS DESIGNATED PURPOSE, WITHOUT THE WRITTEN PERMISSION OF ESB.</small>									
PURPOSE OF ISSUE - PRELIMINARY UNLESS INDICATED									
CLIENT APPROVAL	<input type="checkbox"/>	PLANNING	<input checked="" type="checkbox"/>	TENDER	<input type="checkbox"/>	CONSTRUCTION	<input type="checkbox"/>	AS-BUILT	<input type="checkbox"/>
CLIENT	Oriel Windfarm Limited								
PROJECT	Oriel Wind Farm Project								
CONTRACT									
DRAWING TITLE	ONSHORE SUBSTATION TELECOMMUNICATIONS MAST PLAN AND ELEVATIONS								
PRODUCTION UNIT	Civil, Environmental and Renewable Engineering								
 Engineering and Major Projects, One Dublin Airport Central, Dublin Airport, Cloughran, Co. Dublin, K67 XF72, Ireland. Tel: +353 (0)1 703 8000 Web: www.esb.ie Engineering and Major Projects is a division of ESB.									
DRAWN	PRODUCED	VERIFIED	APPROVED	APPROVAL DATE					
S. Bolton	S. Bolton	S. Donnelly	J. McLoughlin	21/02/2024					
CLIENT REF	TC223815	NO. OF SHTS	1	SIZE	A1	SCALE	1:100		
DRAWING NUMBER			SHEET			REV			
PE605-D027-038-027-002			1			1			